


GENERAL NOTES:

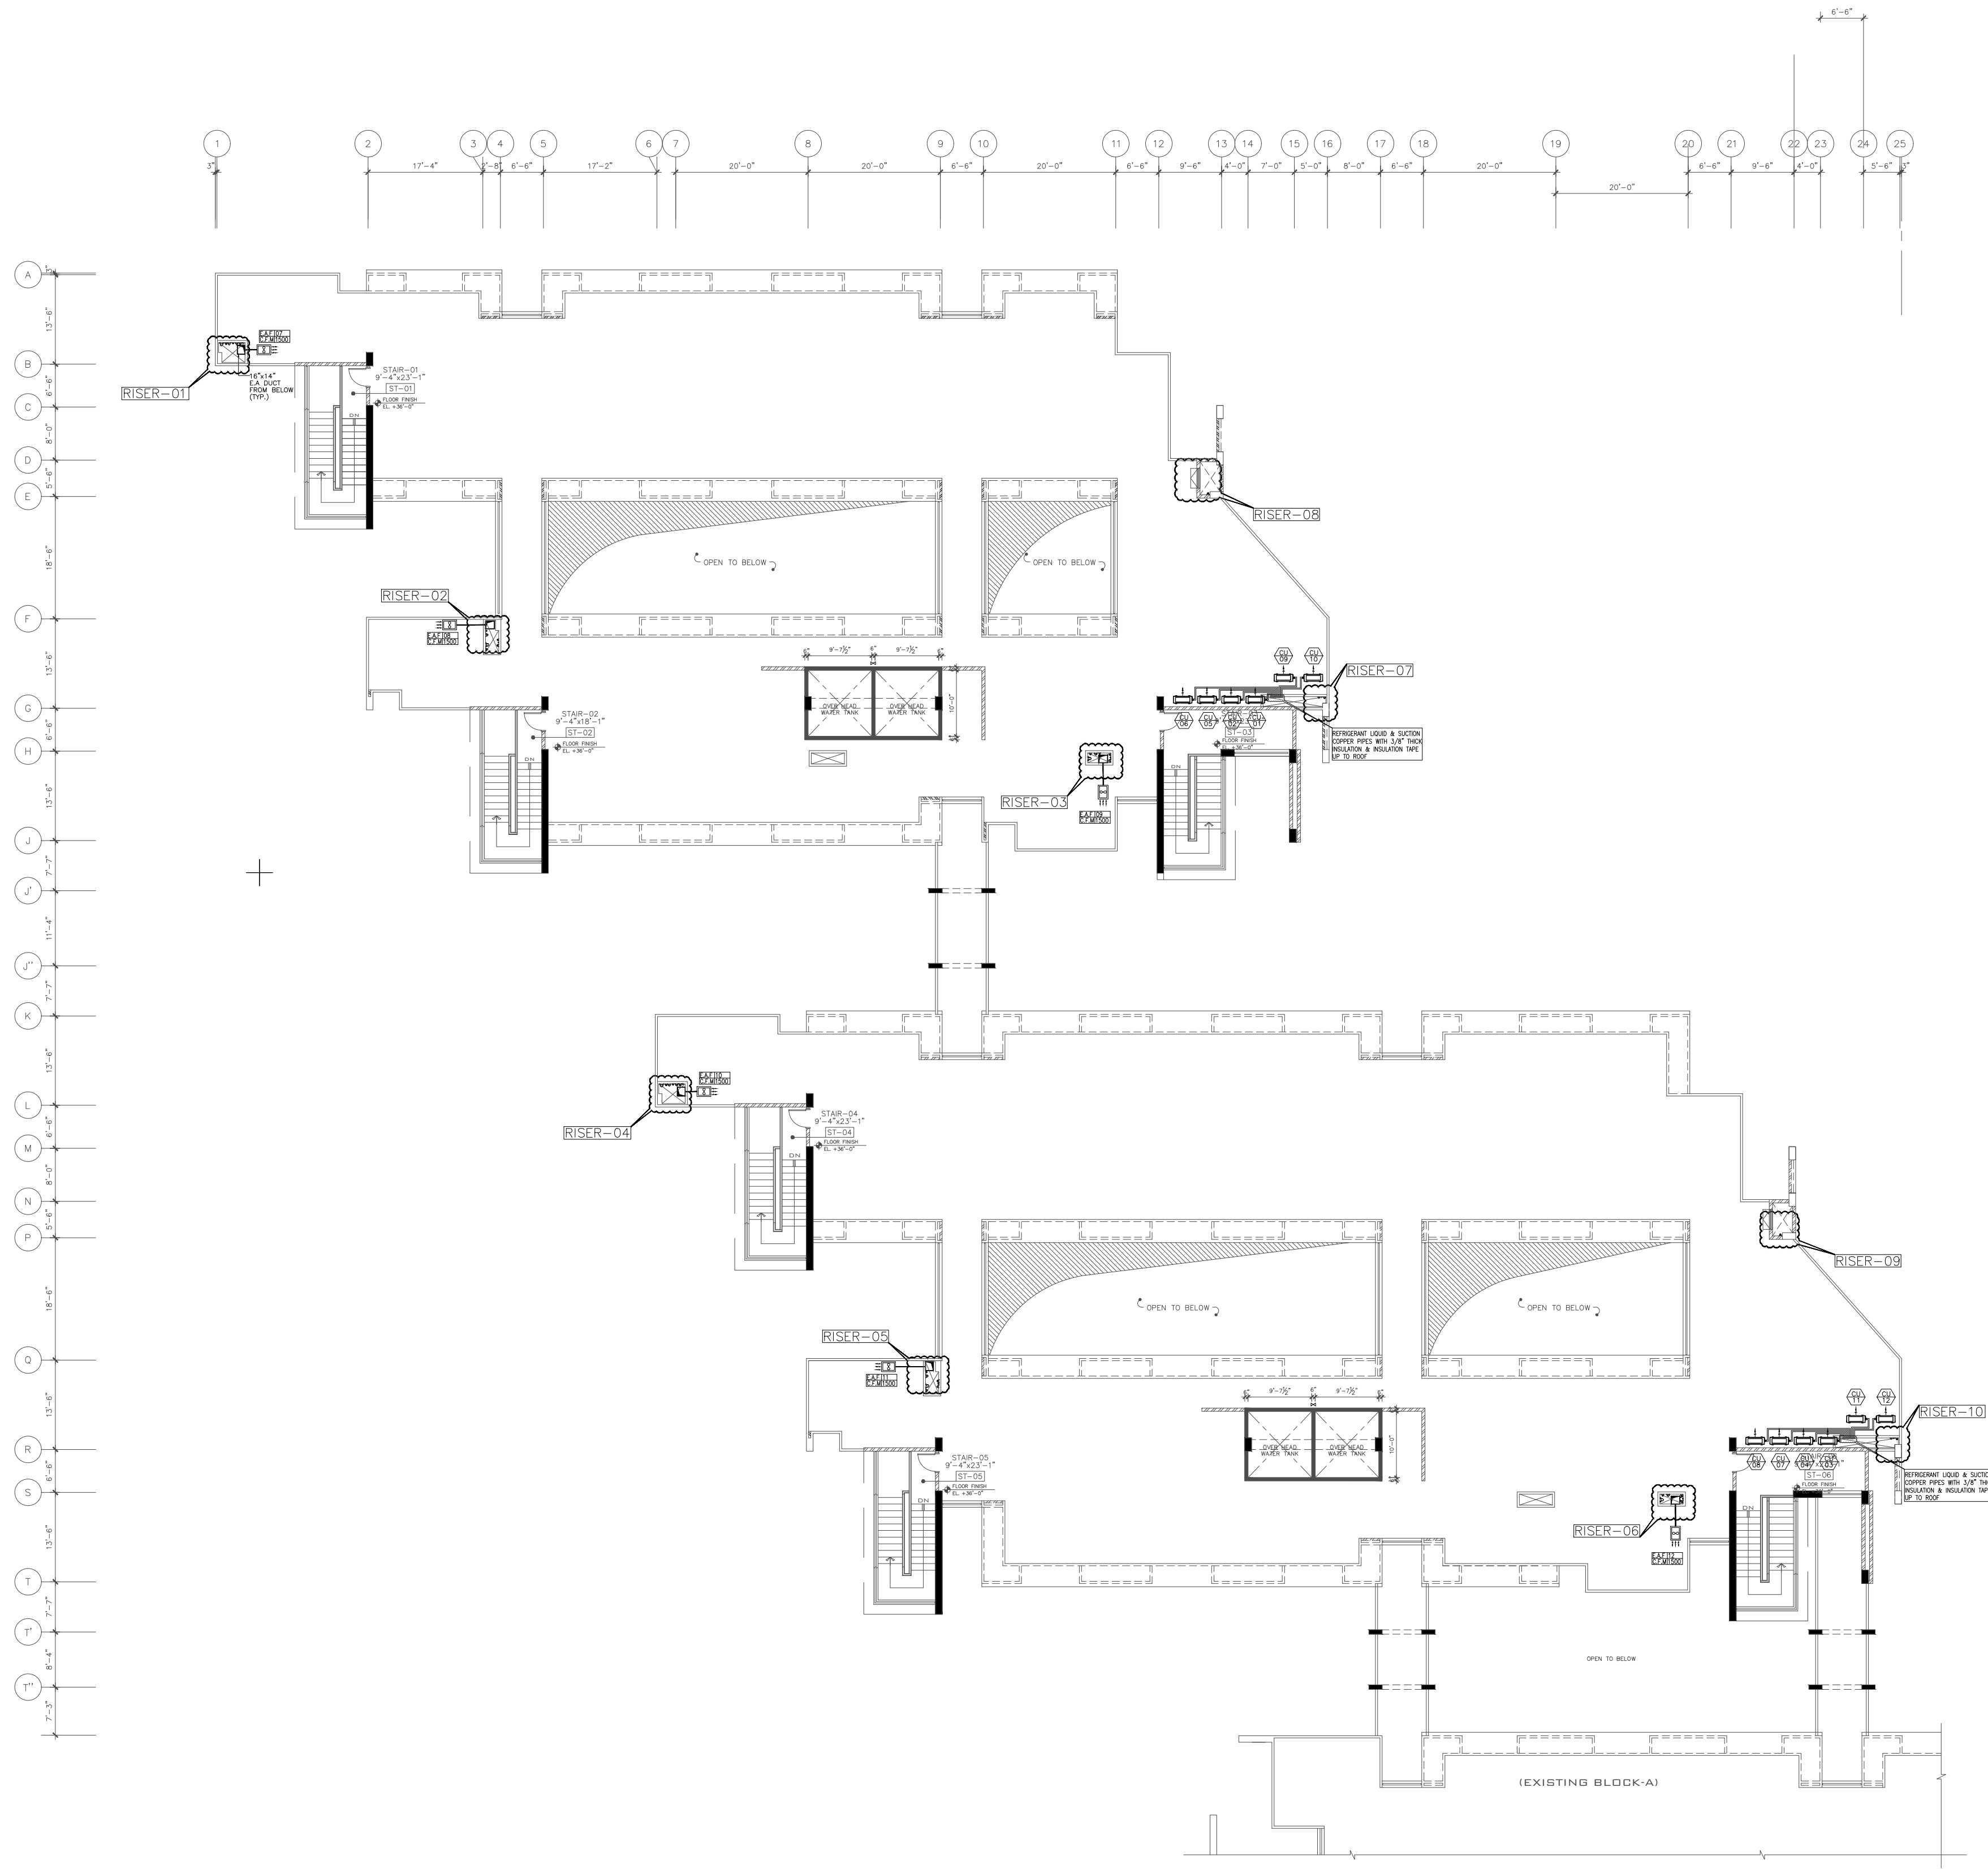

NO.	DATE	REVISION	DESCRIPTION
02	15-05-2014	01	CONSTRUCTION DRAWING
1	28-02-2014	00	TENDER DRAWING

Job : **IBA**  
**NEW BOYS' HOSTEL**  
**MAIN CAMPUS KARACHI**

Title : **HVAC LAYOUT FOR ROOF**

M & P CONSULTANT  
**A+Engineers**  
**M & P Consultants**  
 Suite 713, Anum Blessings,  
 Shahr-e-Faisal Karachi, Pakistan  
 Phone: +92-21-3825466  
 Email: aslanishat@hotmail.com  
 aplusengineers@gmail.com

Design Consultant :  
**N E A D J L M L A B B I G L R G A R T A I M V I E**  
 (PVT.) LTD.  
 14-G, LANE 7, MAIN KH-E-BUKHARI COMMERCIAL,  
 PHASE - VI, D.H.A., KARACHI, PAKISTAN.  
 TEL: +92-21-35242699, 35242692, 35857997, 35857990  
 FAX: +92-21-35857986

STAMP :  
**TENDER DRAWING**

Job Arch : Imran Rasheed    Cad By : KAMRAN  
 Checked: Z.B.    Job No : A-IN-1217  
 Date : APRIL 15, 2017    Scale : 1/16"=1'-0"

NORTH  
  
 Drawing No  
**55-M-05**