


Institute of Business
 Administration
 Karachi

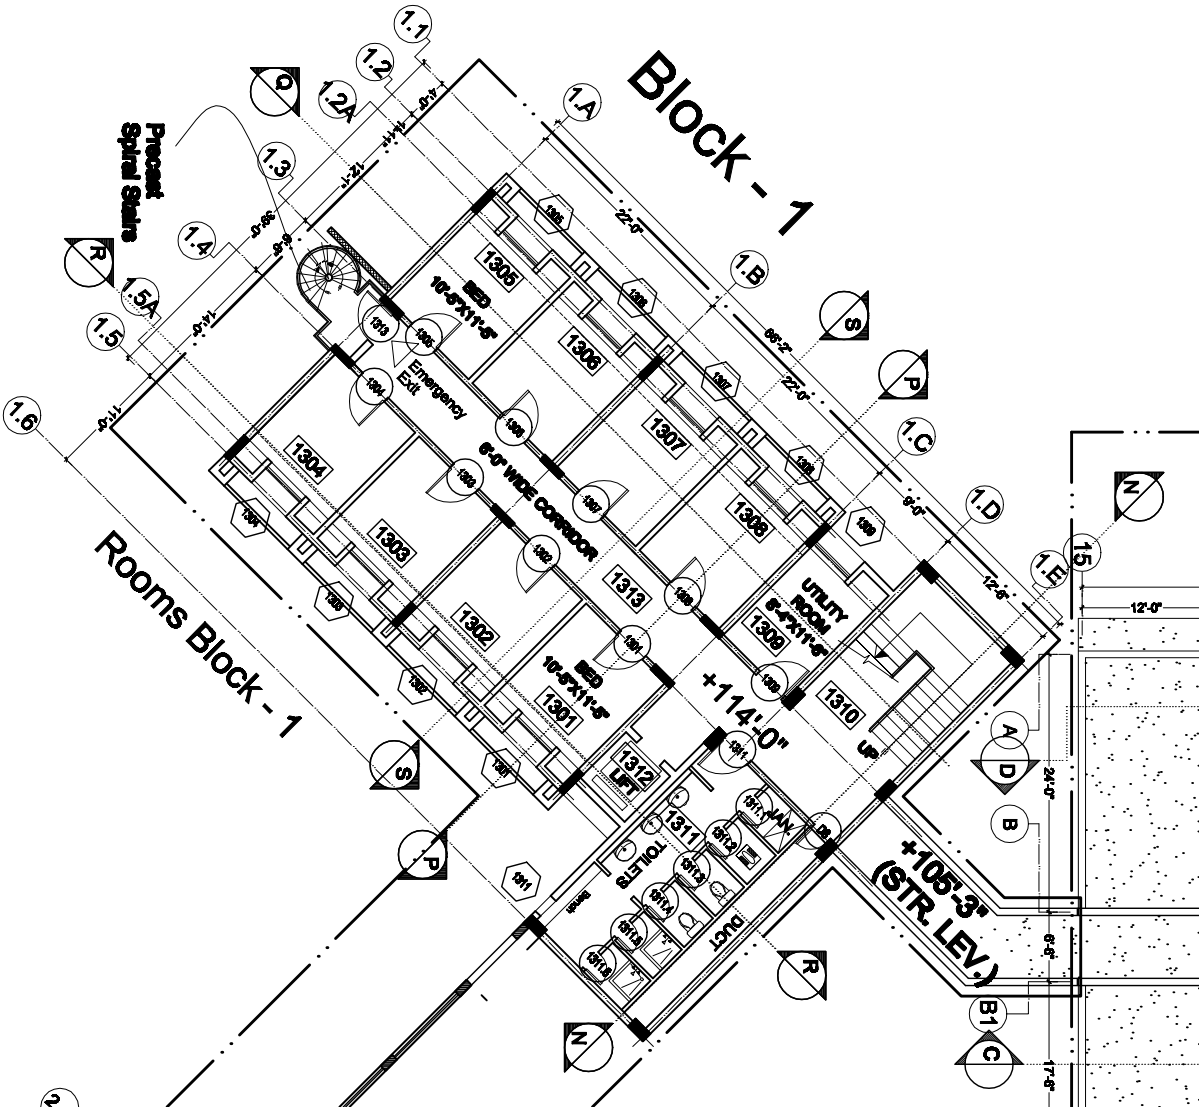
Project Title
**New Girls' Hostel Ph-2
 at The Staff Colony,
 Main Campus, Karachi**

Project & Planning Department
 Institute of Business Administration Karachi,
 University Road, Karachi. Tel: (021 86102700)
 Web site : www.iba.edu.pk

STRUCTURAL CONSULTANT:

HAMEEDY CONSULTANTS
 CONSULTING ENGINEERS
 Ph: 3541477, 034-383878
 Email: hammad@hameedy.com

Date	June 30 2021	Scale	1/8" = 1'-0"
Drawn by	IRBAN	Checked by	AWW - 43.2
Approved by	Nashim		

Second Floor Plan



Roof Plan

