

**GENERAL NOTES:**  
 1. ALL DIMENSION ARE MENTIONED IN FEET & INCHES. OTHERWISE SPECIFIED.  
 2. WIRING OF DIFFERENT SYSTEM SHALL BE IN SEPARATE CONDUIT.  
 3. MINIMUM SIZE OF CONDUIT IS 25MM DIA.

**PROJECT NAME:**  
 CEE HALL FYSAL BUILDING

**DRAWING TITLE:**  
 CEE HALL FYSAL BUILDING  
 LIGHTING LAYOUT

**DRAWN BY:**  
 H.I

**CHECKED BY:**  
 -

**APPROVED BY:**  
 -

**DATE:**  
 26/02/2026

**CLIENT**  
 INSTITUTE OF BUSINESS  
 ADMINISTRATION  
 KARACHI, PAKISTAN

**PROJECT & PLANNING**  
 DEPARTMENT  
 INSTITUTE OF BUSINESS ADMINISTRATION  
 UNIVERSITY ROAD KARACHI, TEL:02138104700  
 WEBSITE: www.iba.edu.pk

**PROJECT NO.:**  
 -

 
**DRAWING NO.:**  
 EE-LL-01

**REVISION:**  
 -


**UNIT:**  
 -

**SCALE:**  
 0:000

**SHEET NO.:**  
 1 OF 1



**SHEET SIZE:**  
 A3

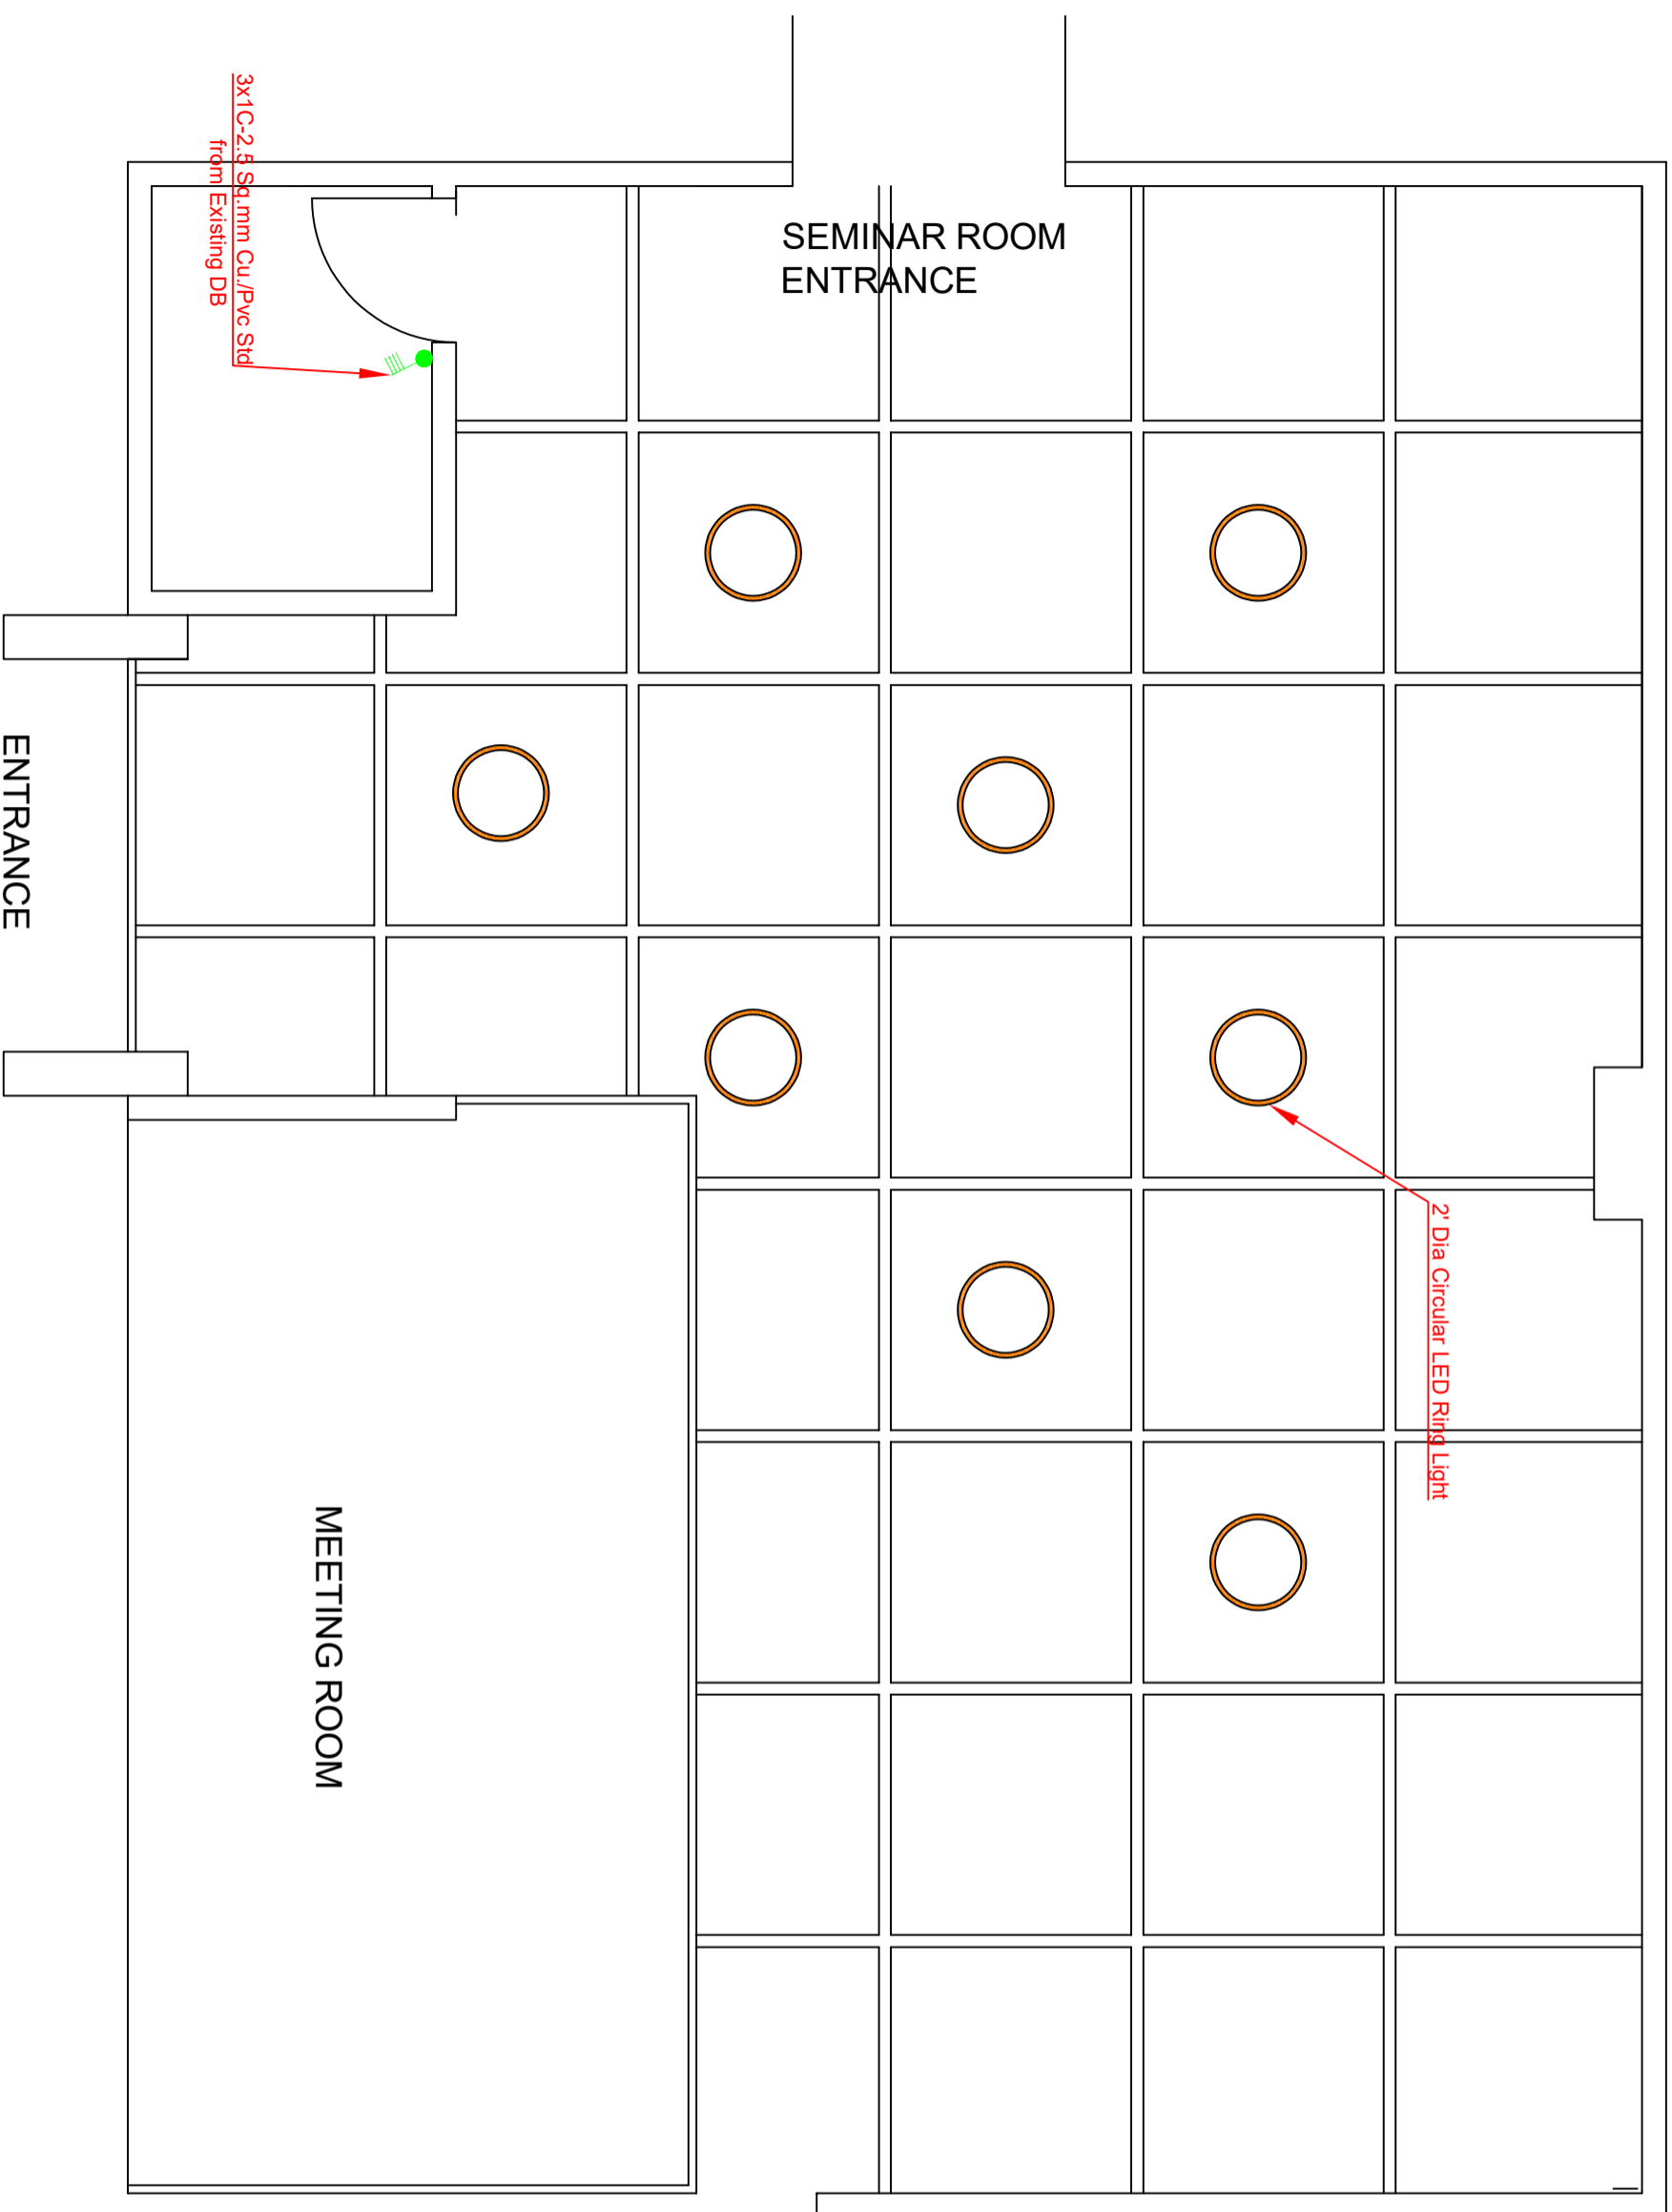

REV.	DESCRIPTION:	BY:	DATE:
0	ISSUED FOR REVIEW & APPROVAL	H.I	26/02/2026